


FLOOR PLAN KEY NOTES:

- 1 225A 120/208V ELEC. PANEL
- 2 40 GALLON WATER HEATER
- 3 HW, CW, AND DRAIN STUBS FOR FUTURE PLUMBING SINK/LAVATORY
- 4 APPROXIMATE LOCATION OF RTU ABOVE
- 5 EXPOSED CMU WALL
- 6 INTERIOR WINDOW
- 7 MOP SINK & FAUCET
- 8 ALUM. FRAMED STOREFRONT SYSTEM w/ 1/4" TH. CLEAR GLAZING
- 9 LINE OF CANOPY OVERHEAD
- 10 GYPSUM DEMISING WALL
- 11 ASPHALT DRIVE
- 12 CONCRETE SIDEWALK
- 13 STEEL COLUMN
- 14 CONCRETE CURB
- 15 DOWNSPOUT
- 16 BANK OF ELECTRIC METERS
- 17 ELECTRIC TRANSFORMER
- 18 WATER METER

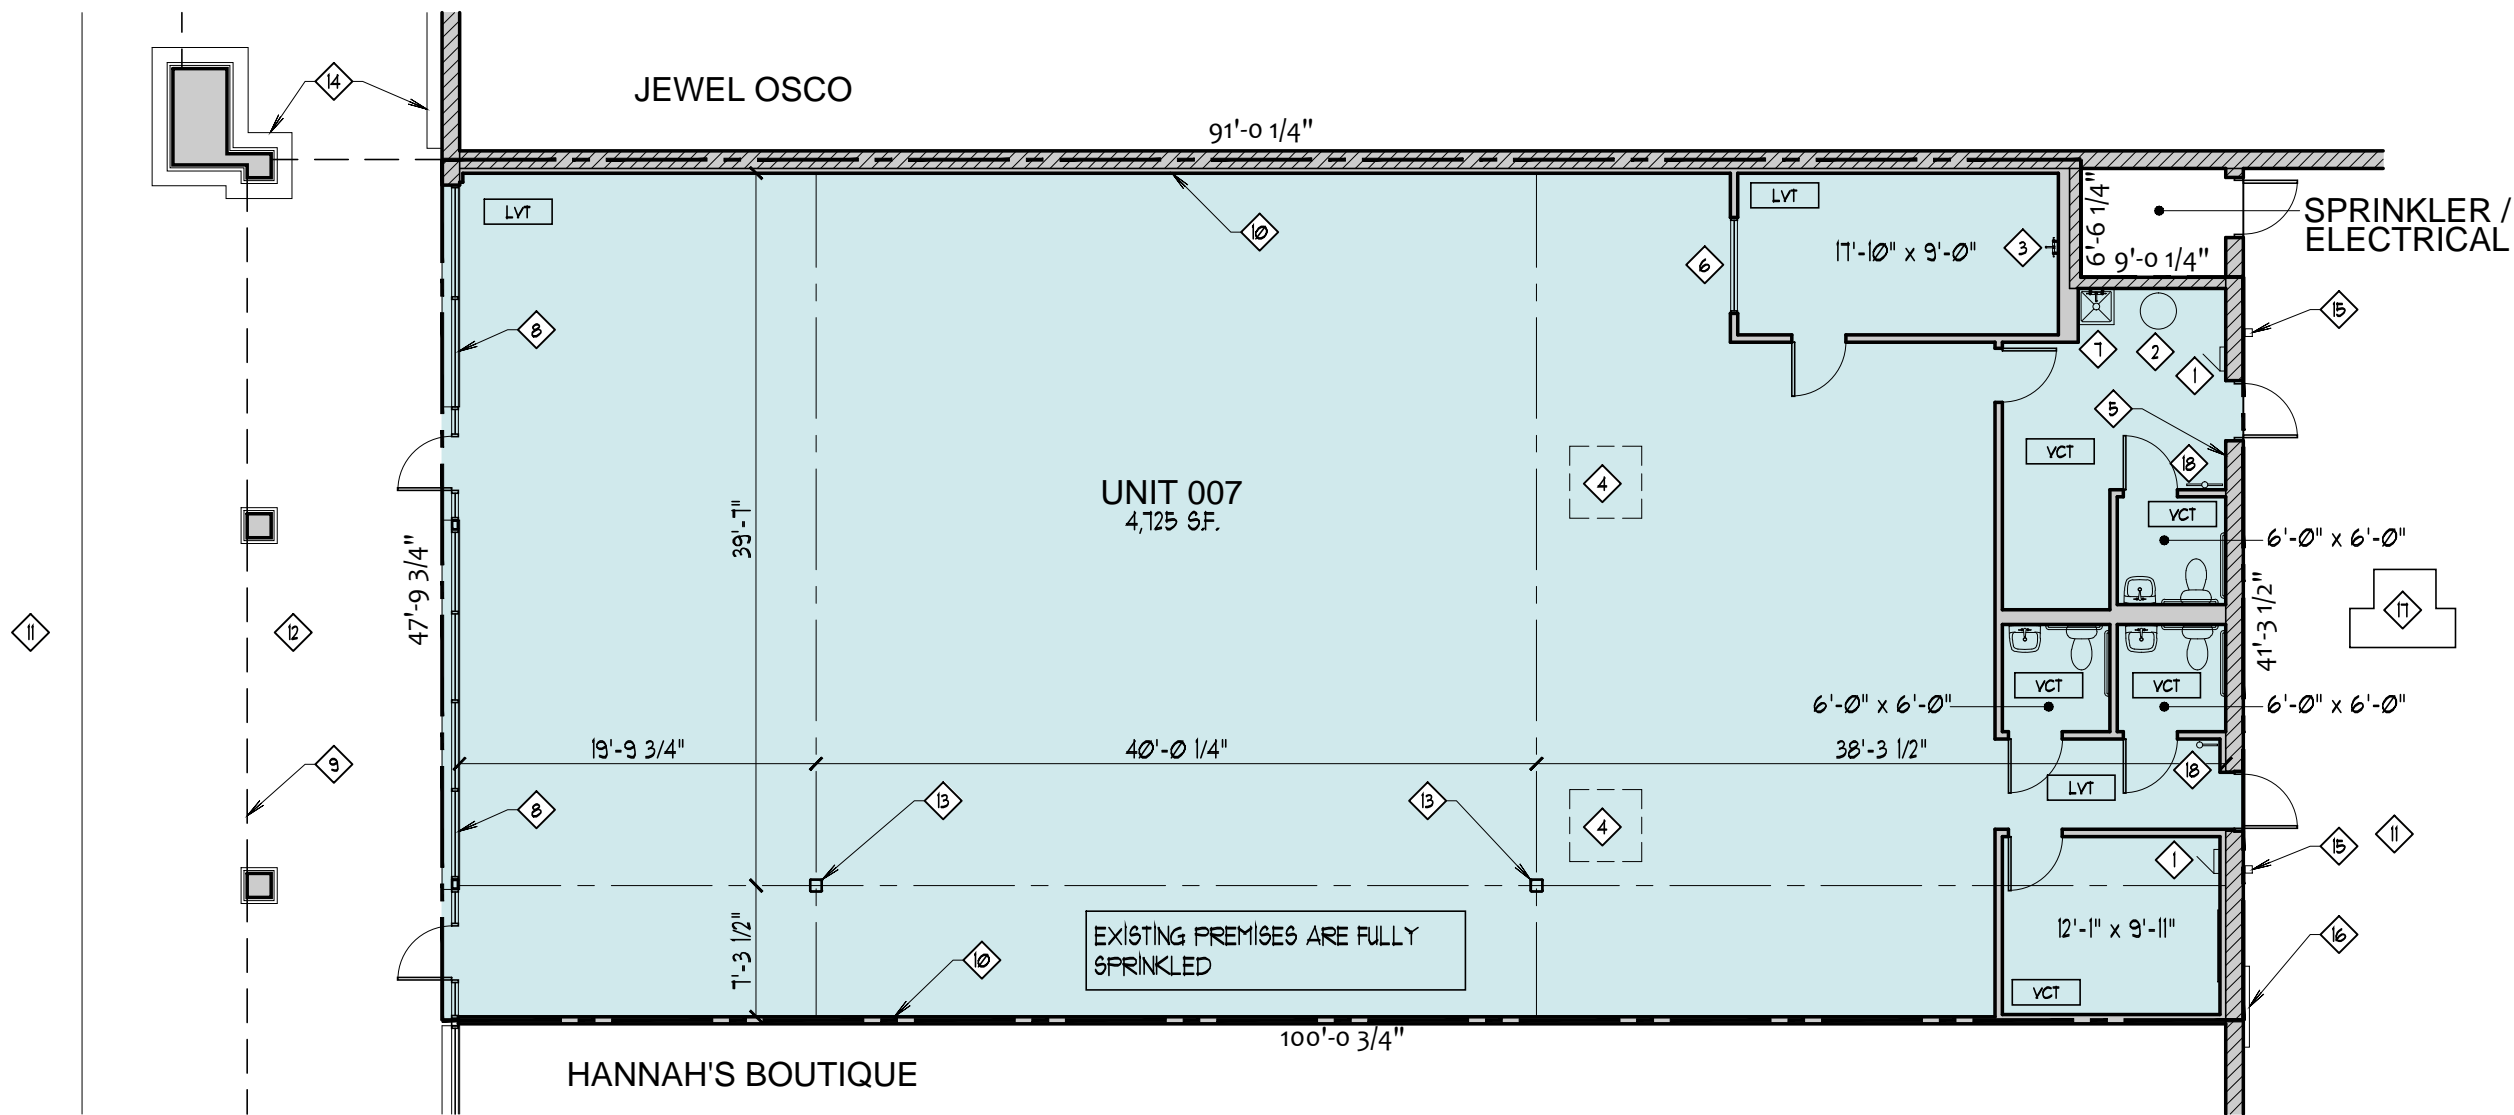

FLOOR PLAN
 SCALE: 3/32" = 1'-0"