
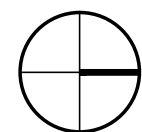


FLOOR PLAN KEY NOTES:

- 1 225A 120/208V ELEC. PANEL
- 2 6 GALLON ELECTRIC WATER HEATER ABOVE RESTROOM CEILING
- 3 EXPOSED CMU WALL
- 4 ALUM. FRAMED STOREFRONT SYSTEM w/ 1/4" TH. CLEAR GLAZING
- 5 LINE OF CANOPY OVERHEAD
- 6 GYPSUM DEMISING WALL
- 7 BANK OF GAS METERS
- 8 ELECTRIC METER
- 9 ASPHALT DRIVE
- 10 CONCRETE SIDEWALK
- 11 EXPOSED STEEL COLUMN
- 12 ELECTRIC TRANSFORMER
- 13 CONCRETE CURB
- 14 WATER METER WITHIN PARTITION WALL
- 15 DOWNSPOUT

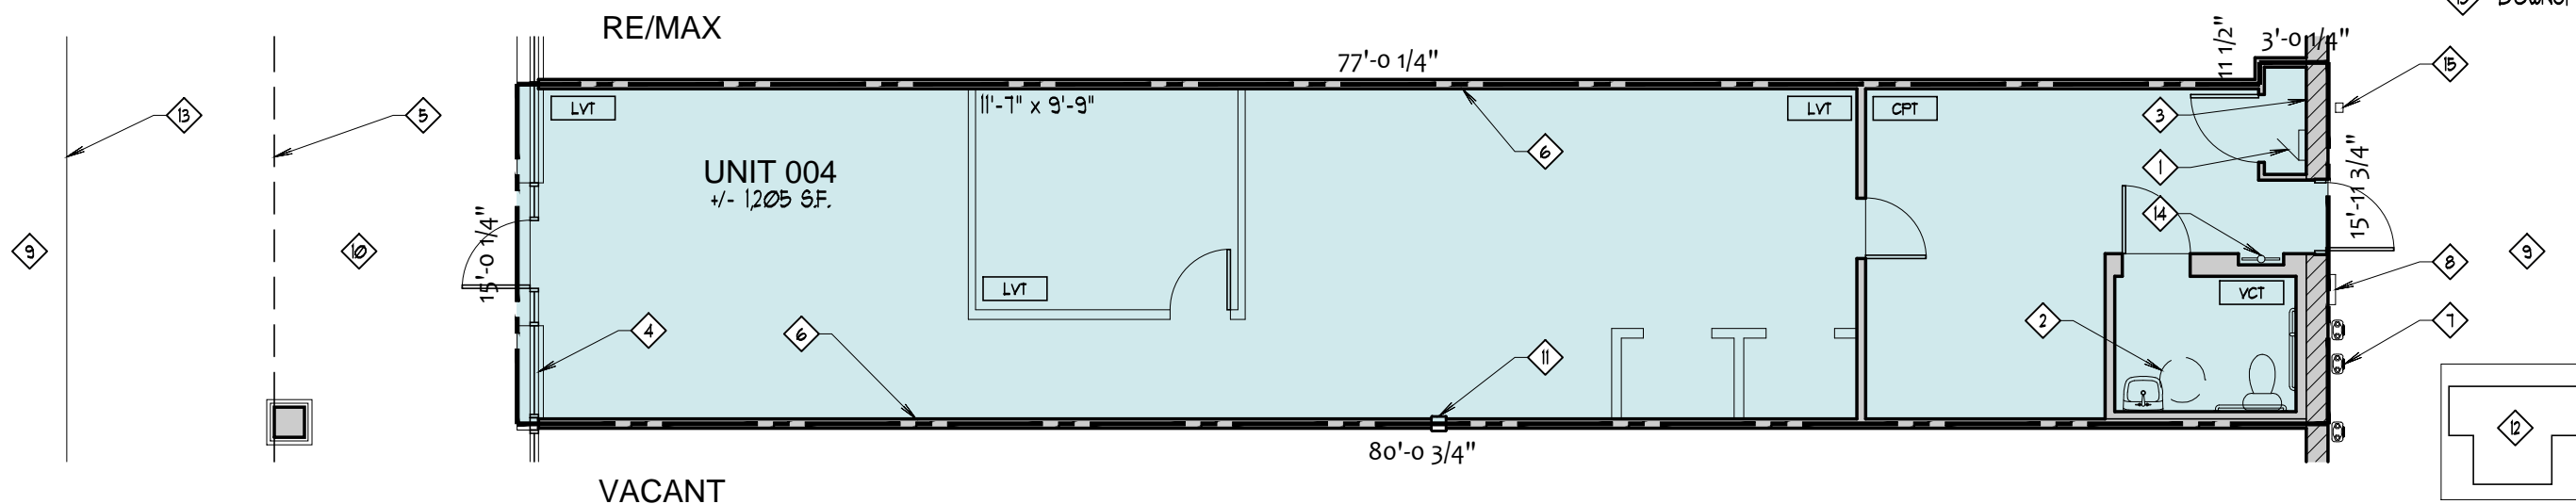

FLOOR PLAN

SCALE: 1/8" = 1'-0"

EXISTING PREMISES ARE FULLY SPRINKLED